


C:\WINDOWS\DESKTOP\PROJECTS\MCCALL FOUNDATION PROJECTS\883 MAIN STREET MCCALL FOUNDATION\883 MAIN STREET PAVING PLAN.DWG.DWG 5/14/24 5:14 PM

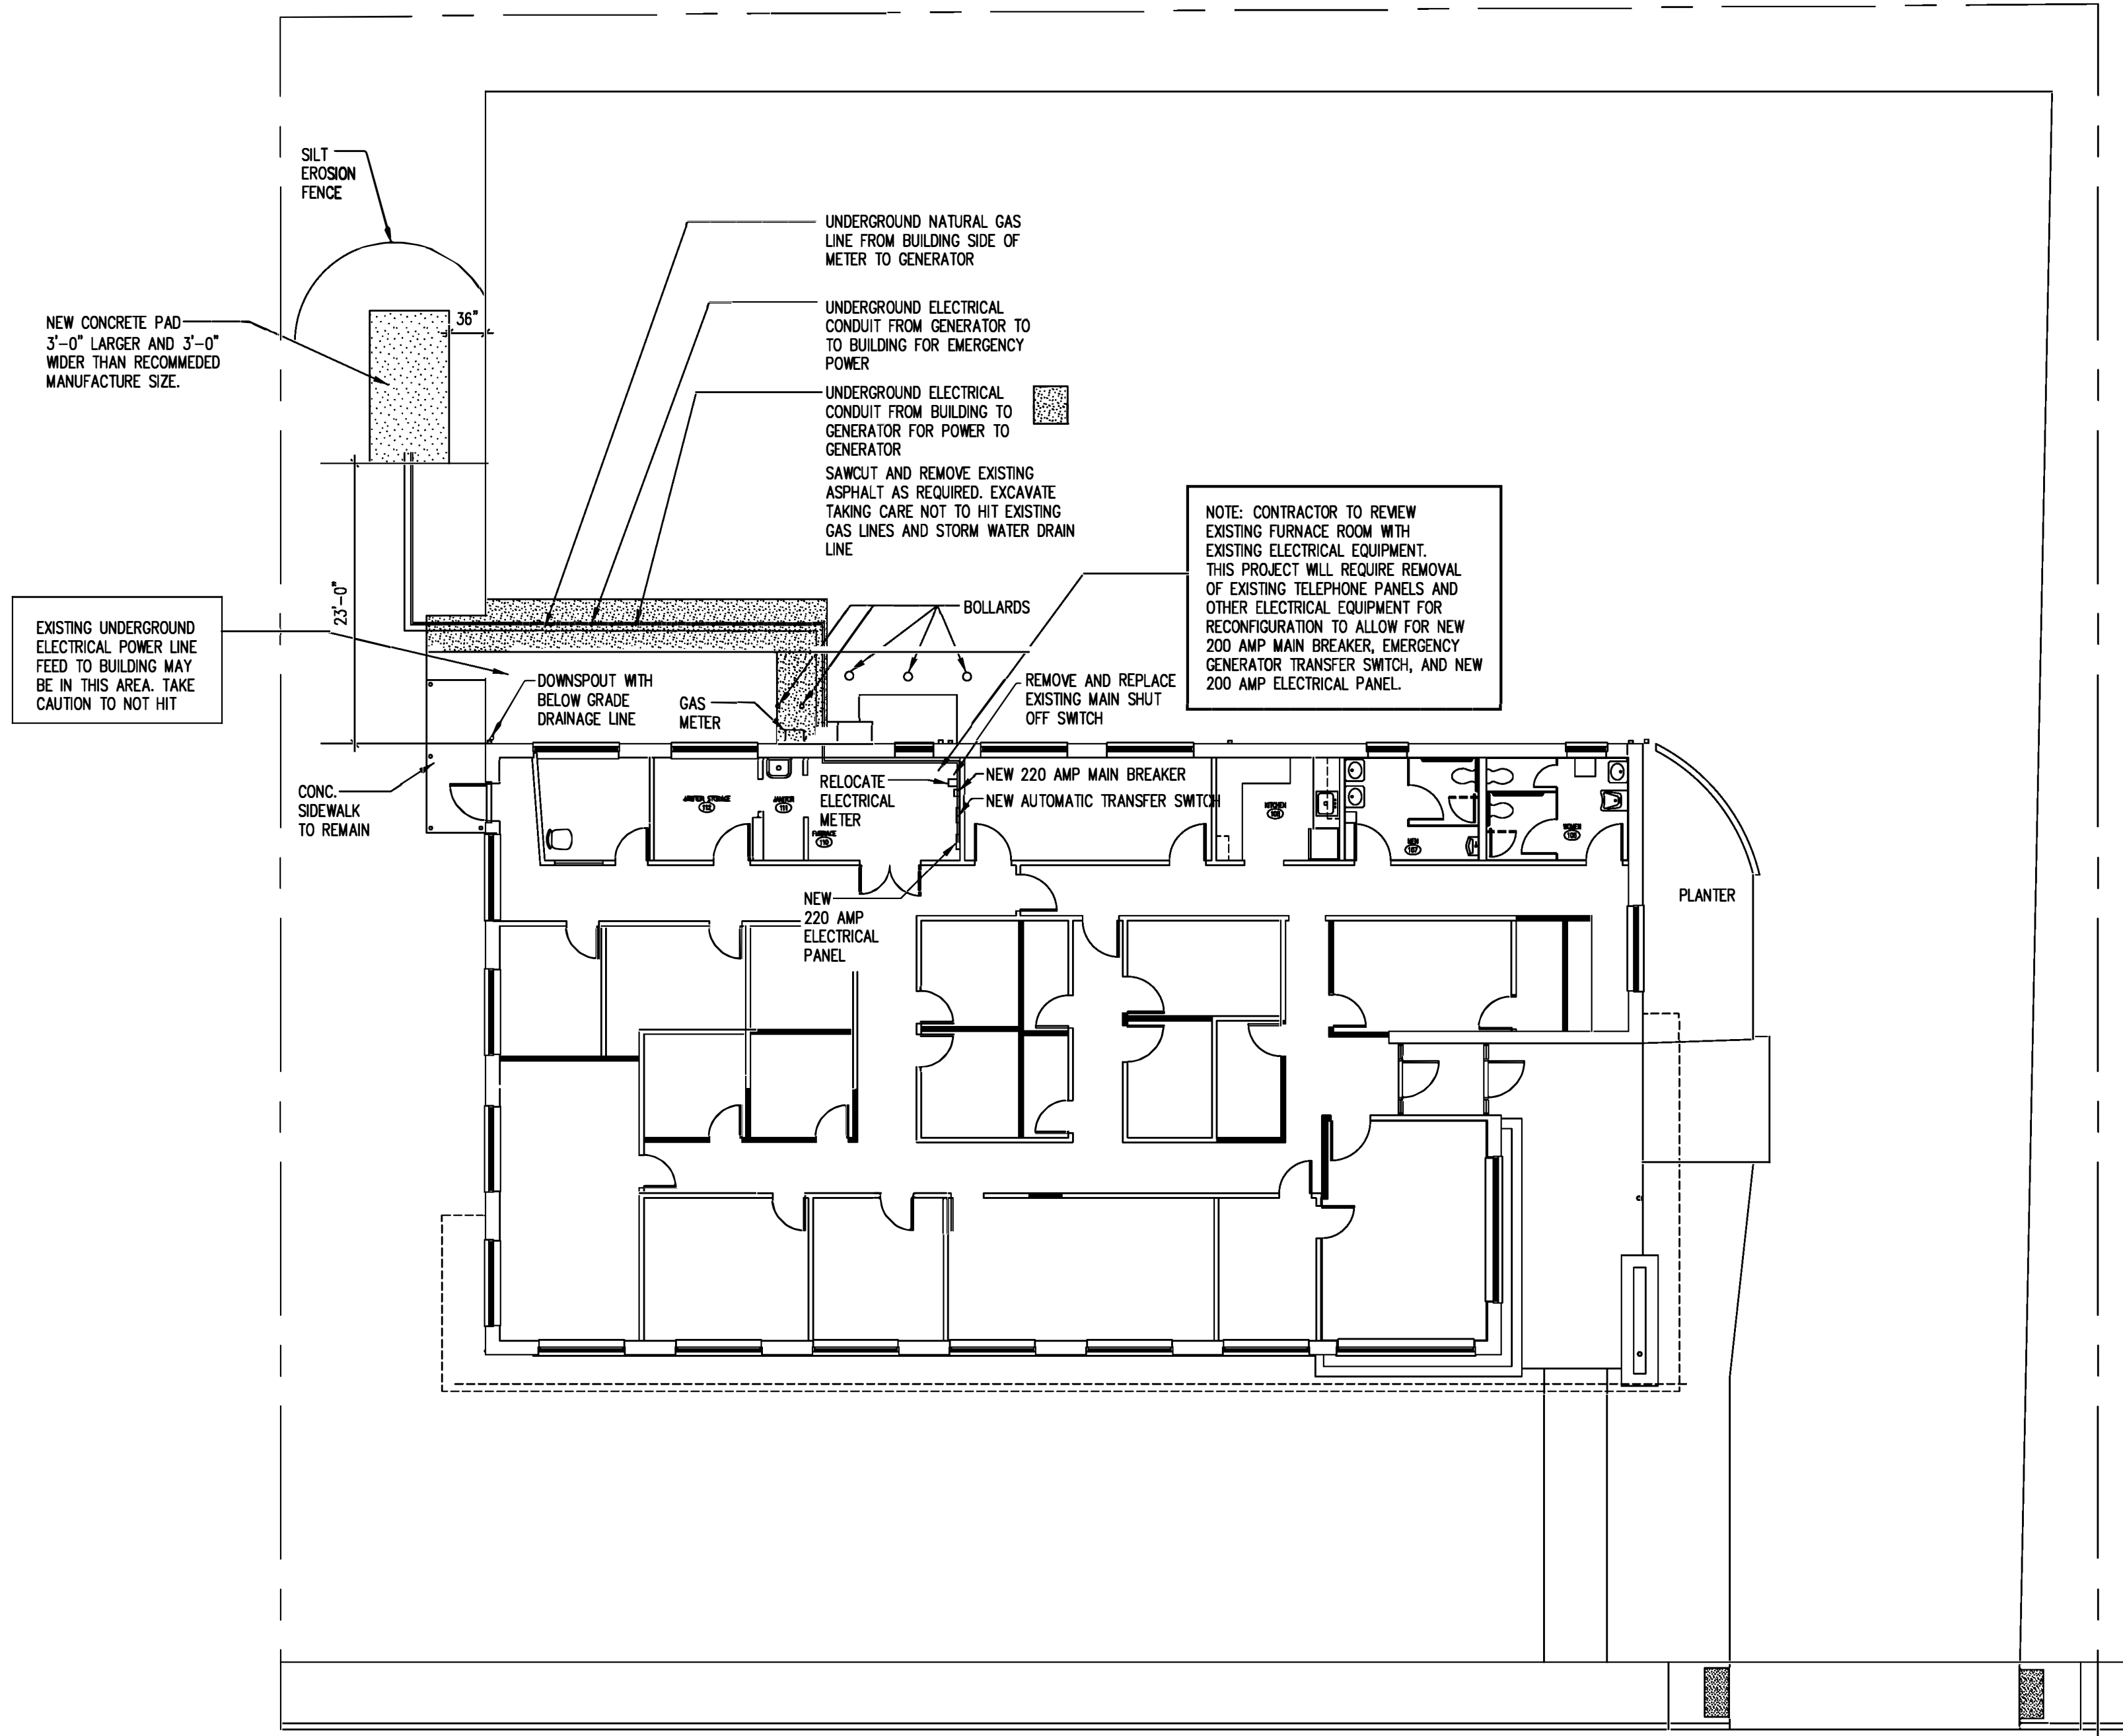


1 GENERATOR SITE PLAN  
SP1 1/10"=1'-0"

CALL BEFORE YOU  
DIG TO IDENTIFY  
LOCATION OF ALL  
CITY UTILITY LINES  
AND AQUARIAN WATER  
LINE.

McCALL FOUNDATION INC.  
EMERGENCY NATURAL GAS  
STAND-BY GENERATOR  
833 MAIN STREET, TORRINGTON, CT

Revisions:	Mark	Date

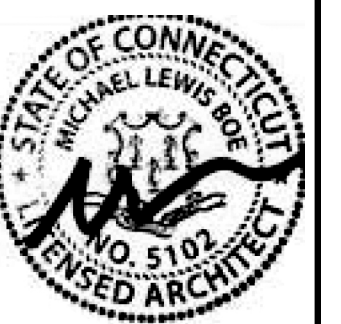

Drawing Title:  
GENERATOR SITE PLAN

Date 6/26/2024  
Scale 1/10"=1'-0"  
Job No.  
CDN.

Drawing No.  
SP1

BOE STUDIO  
architects  
19 Tioga Street Torrington, CT 06790  
e-mail: mboestudio@gmail.com  
PHONE/FAX 860-307-6816